

California Career Pathways Consortia

February 28 - March 2, 2010

HYATT REGENCY ORANGE COUNTY


Garden Grove, California

REVISION DATE:
7/24/2009 KB

BOOTH COUNT

Inventory as of 07/24/2009

Dimension	Size	Qty	SqF
8'x10'	80	50	4,000
Totals:		50	4,000

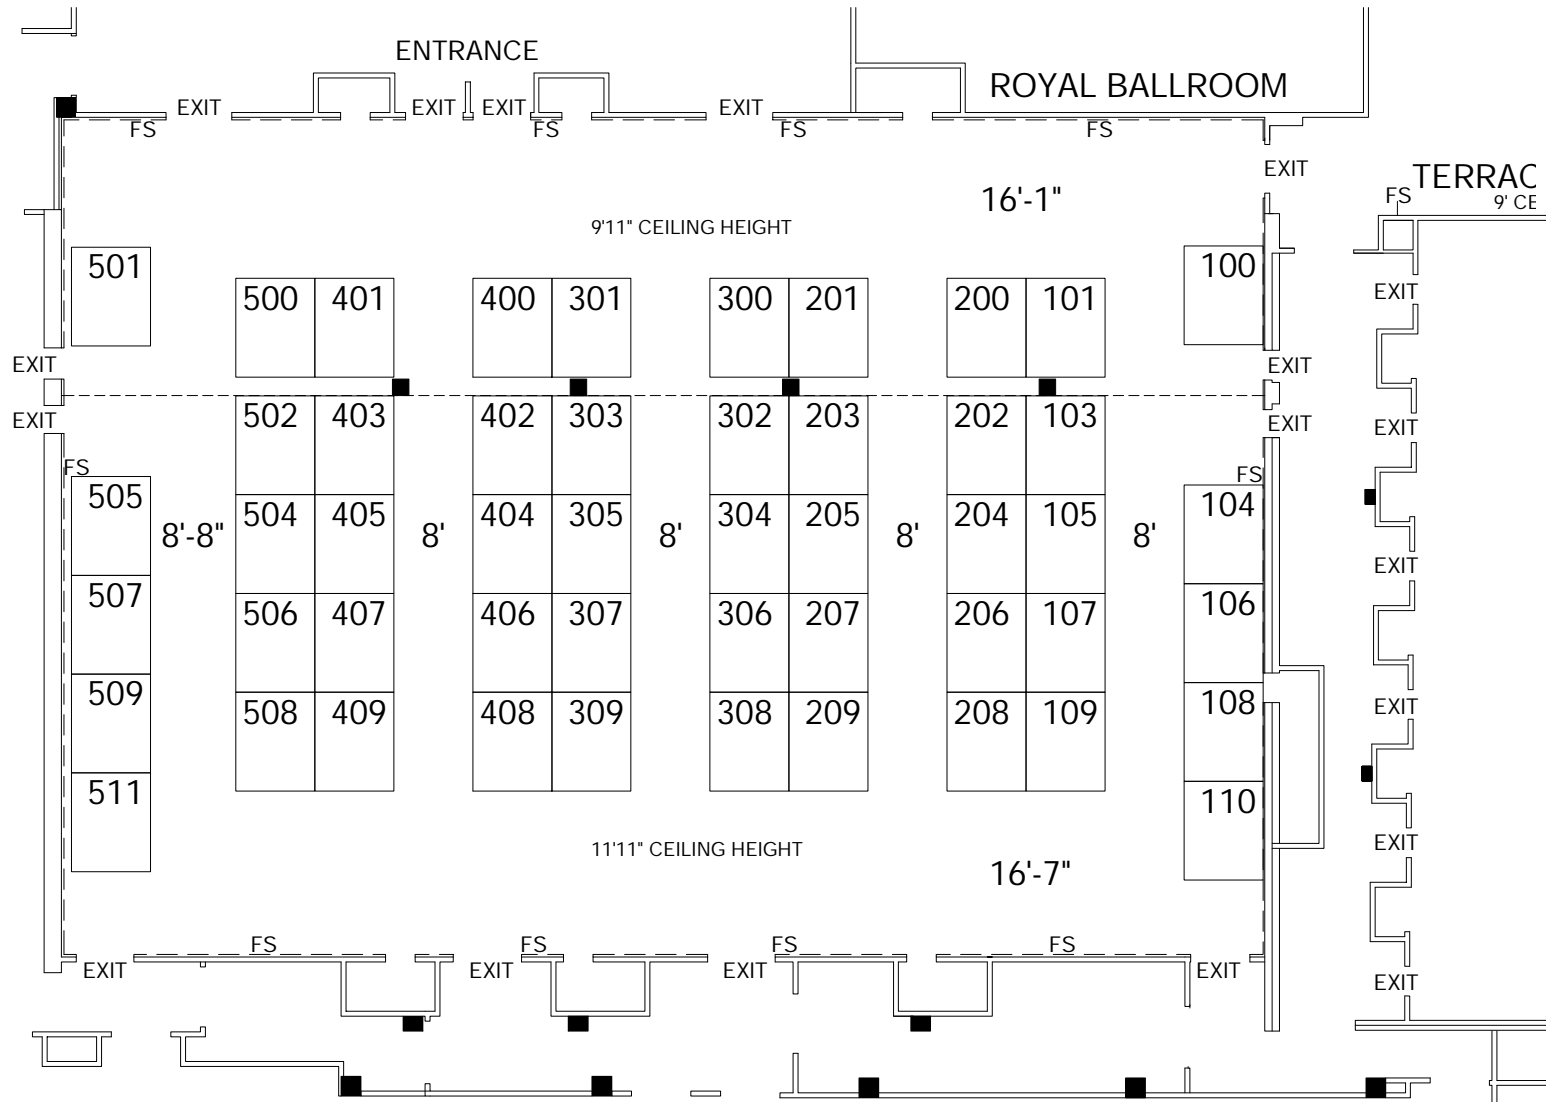

BLDG. LEGEND:

FIRE EQUIPMENT LAYER

- FH - FIRE HOSE
- ⊕ - FIRE EXTINGUISHER
- FS - FIRE STROBE @ 6'8" HIGH
- FA - FIRE ALARM

FREEMAN

DRAWING STARTED:
7/24/2009 KB

FILE PATH:
O:\Design\master\201002 February\California Career Pathways
Consortia\Floor Plans\CCPC 2010.dwg

DRAWING NAME:
CCPC 2010

HALL NAME:
ROYAL BALLROOM

JOB NUMBER:
241888

 
ACCT. EXEC.:
DEBB DUFF

NOT TO SCALE

DISCLAIMER

EVERY EFFORT HAS BEEN MADE TO ENSURE THE ACCURACY OF ALL INFORMATION CONTAINED ON THIS FLOORPLAN. HOWEVER NO WARRANTY EITHER EXPRESSED OR IMPLIED ARE MADE WITH RESPECT TO THIS FLOORPLAN IF THE LOCATION OF BUILDING COLUMN UTILITIES OR OTHER ARCHITECTURAL COMPONENTS OF THE FACILITY IS A CONSIDERATION IN THE CONSTRUCTION OR USAGE OF AN EXHIBIT, IT IS THE SOLE RESPONSIBILITY OF THE EXHIBITOR TO PHYSICALLY INSPECT THE FACILITY TO VERIFY ALL DIMENSIONS AND LOCATION.

©COPYRIGHT 2007, FREEMAN CO.
ALL RIGHTS RESERVED.



NOTE: - ALL AISLES ARE 10' UNLESS OTHERWISE SPECIFIED.
- FLOOR PLAN IS SUBJECT TO CHANGE.
- FLOOR PLAN IS SUBJECT TO FIRE MARSHAL APPROVAL.

DRAWING AS OF: 07/24/09